


SCALE 0.500

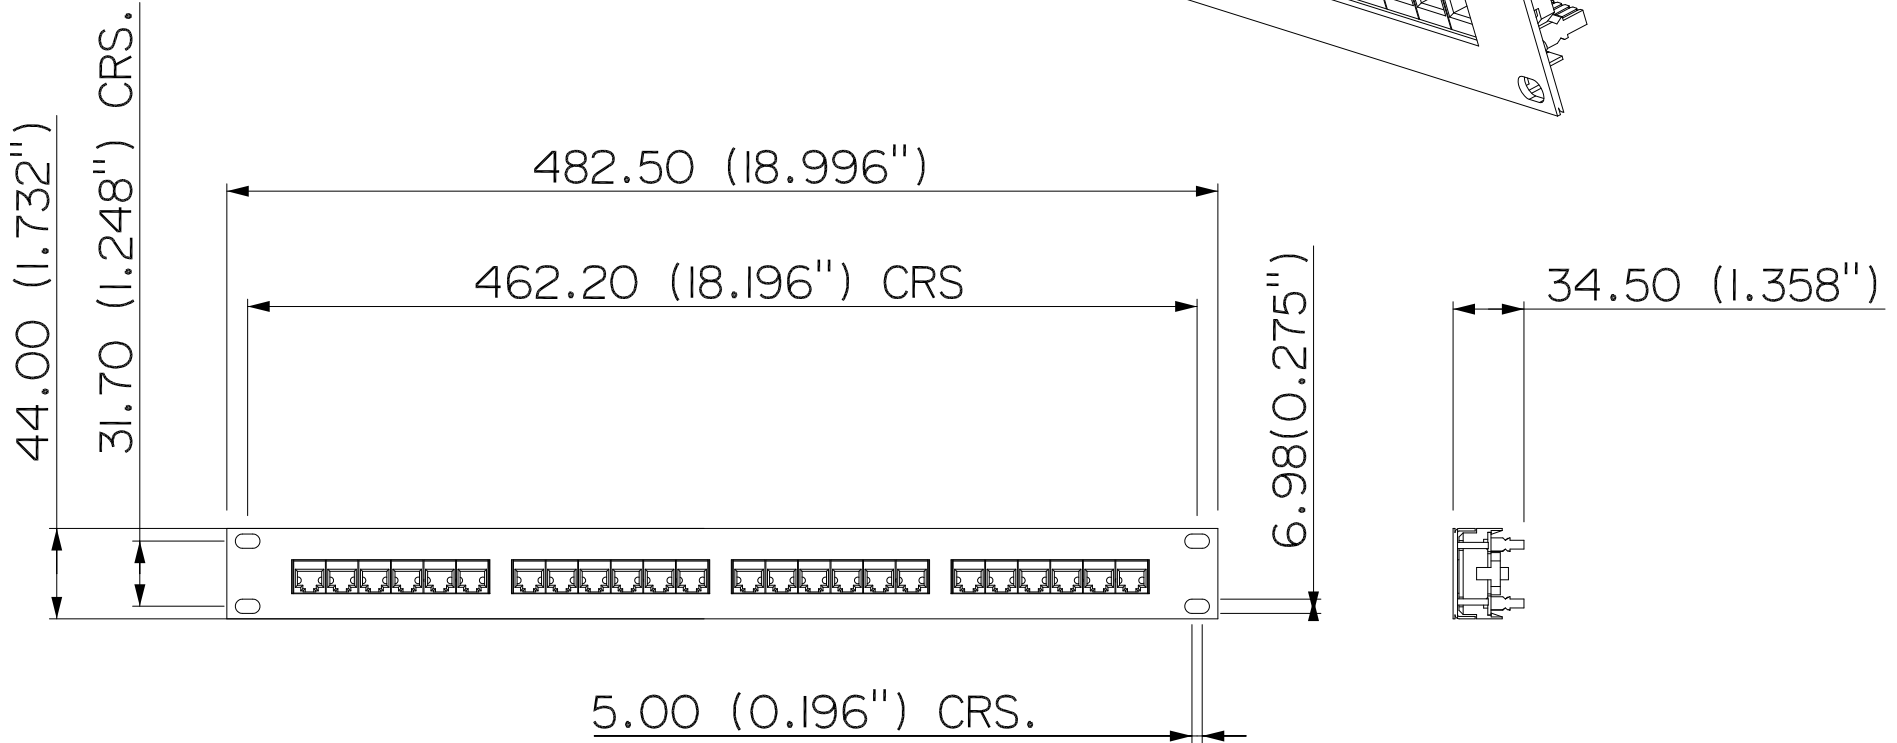

HellermannTyton
 Structured Cabling Products

ALL PROPRIETARY RIGHTS IN THE SUBJECT MATTER SHOWN ON THIS DRAWING ARE EXCLUSIVE PROPERTY OF HELLERMANN TYTON

Name	Date	City, State
S.PONTING	24/01/01	NORTHAMPTON U.K

REVISION

D level	2
by	S.PONTING
date	19/05/14
ECN #	
part level	2

DIMENSIONS

T .XXX= ±0.001
 .XXX= ±0.010
 .XX= ±0.02
 .X= ±0.1
 <= ±0.5

unless otherwise specified
 units mm / inches

PART

number	PP110C624	phase	PRODUCTION
name	CAT 6 1U 24 PORT 110 UNIVERSAL PATCH PANEL		
material	N/A		

DRAWING

FORMAT AH version J	CAD PRO-E	scale 0.280
computer file number	previous number	
drawn S.Ponting	checked	approved
24/08/01		
type	sheet 1 of 1	
number	P155-013	